
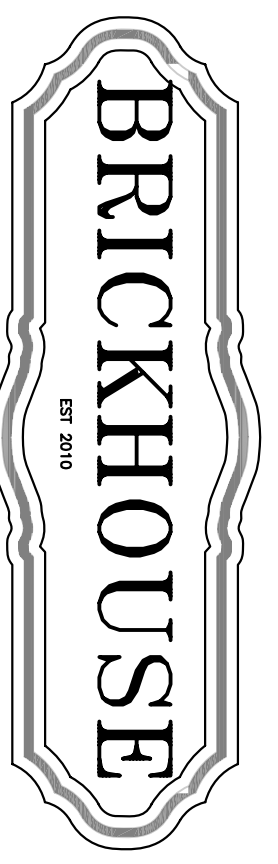


40	20	3	KINGERS HANDSINK HS-1000
41	21	1	KINGERS ET-3-20 SINK (3 COMP)
42	22	1	KINGERS BAR-3-20 SINK (3 COMP)
43	23	1	KINGERS ET-2-20 SINK (2 COMP)
44	24	1	DRENCH HANDSINK (41)
45	25	1	DRENCH HANDSINK (41)
46	26	1	CLEAN DISH TABLE (41)
47	27	1	SS TABLE 30" X 72"
48	28	1	SS TABLE 30" X 48 GOLD PLATE
49	29	1	36" FOR BINS WITH COOLD PLATE
50	30	1	ARCHIVED KITCHEN PANTRY PRESS 188018
51	31	1	ARCHIVED KITCHEN PANTRY PRESS 188018
	32	4	4-TIER SHELF 24" X 36" GREEN EPOXY
	33	1	ASDF
	34	1	ASDF
	35	1	ASDF
	36	1	ASDF
	37	1	ASDF
	38	1	ASDF
	39	1	ASDF

ITEM NO.	DESCRIPTION
1	ASCEND JFD-23R REFRIGERATOR
2	ASCEND JFD-23R REFRIGERATOR
3	SCOTSMAN C1030 CHEF ICE MACHINE
4	TRUMPH HF-5E-240 ELECTRIC SEWING
5	MODEL 1301 CONVECTOR ELECTRIC OVEN
6	WELLS COUNTERTOP GAS CHARBROILER
7	MODEL H08-3630C
8	WELLS COUNTERTOP GAS GRIDDLE
9	MODEL H08-2430G
10	ARCHIVED KITCHEN PANTRY PRESS 188018
11	ARCHIVED KITCHEN PANTRY PRESS 188018
12	IMPERIAL EVC-1 ELEC. CONVECTION OVEN
13	MEMCO 6150-72 INFRARED BAR HEATER
14	TRUO T602-72 REFRIGERATOR BASKET
15	TRUO T602-72 REFRIGERATOR BASKET
16	TRUO T60-45 BACK BAR COOLER
17	SS TABLE 6" (30"X72")
18	SS OVERSHELF W/ HEAT LAMPS (177L)
19	ASDF


FOOD SERVICE EQUIPMENT SCHEDULE & SPECIAL DATA

NOTE: FIRE PROTECTION SUBCONTRACTOR IS TO RECONFIRM EXISTING HEAD LAYOUT TO WORK WITH NEW WALL CONFIGURATION. SUBMIT FIRE PROTECTION DRAWING TO CITY OF LAGRANGE FIRE CHIEF CHRIS SMITH FOR APPROVAL PRIOR TO INSTALLATION.

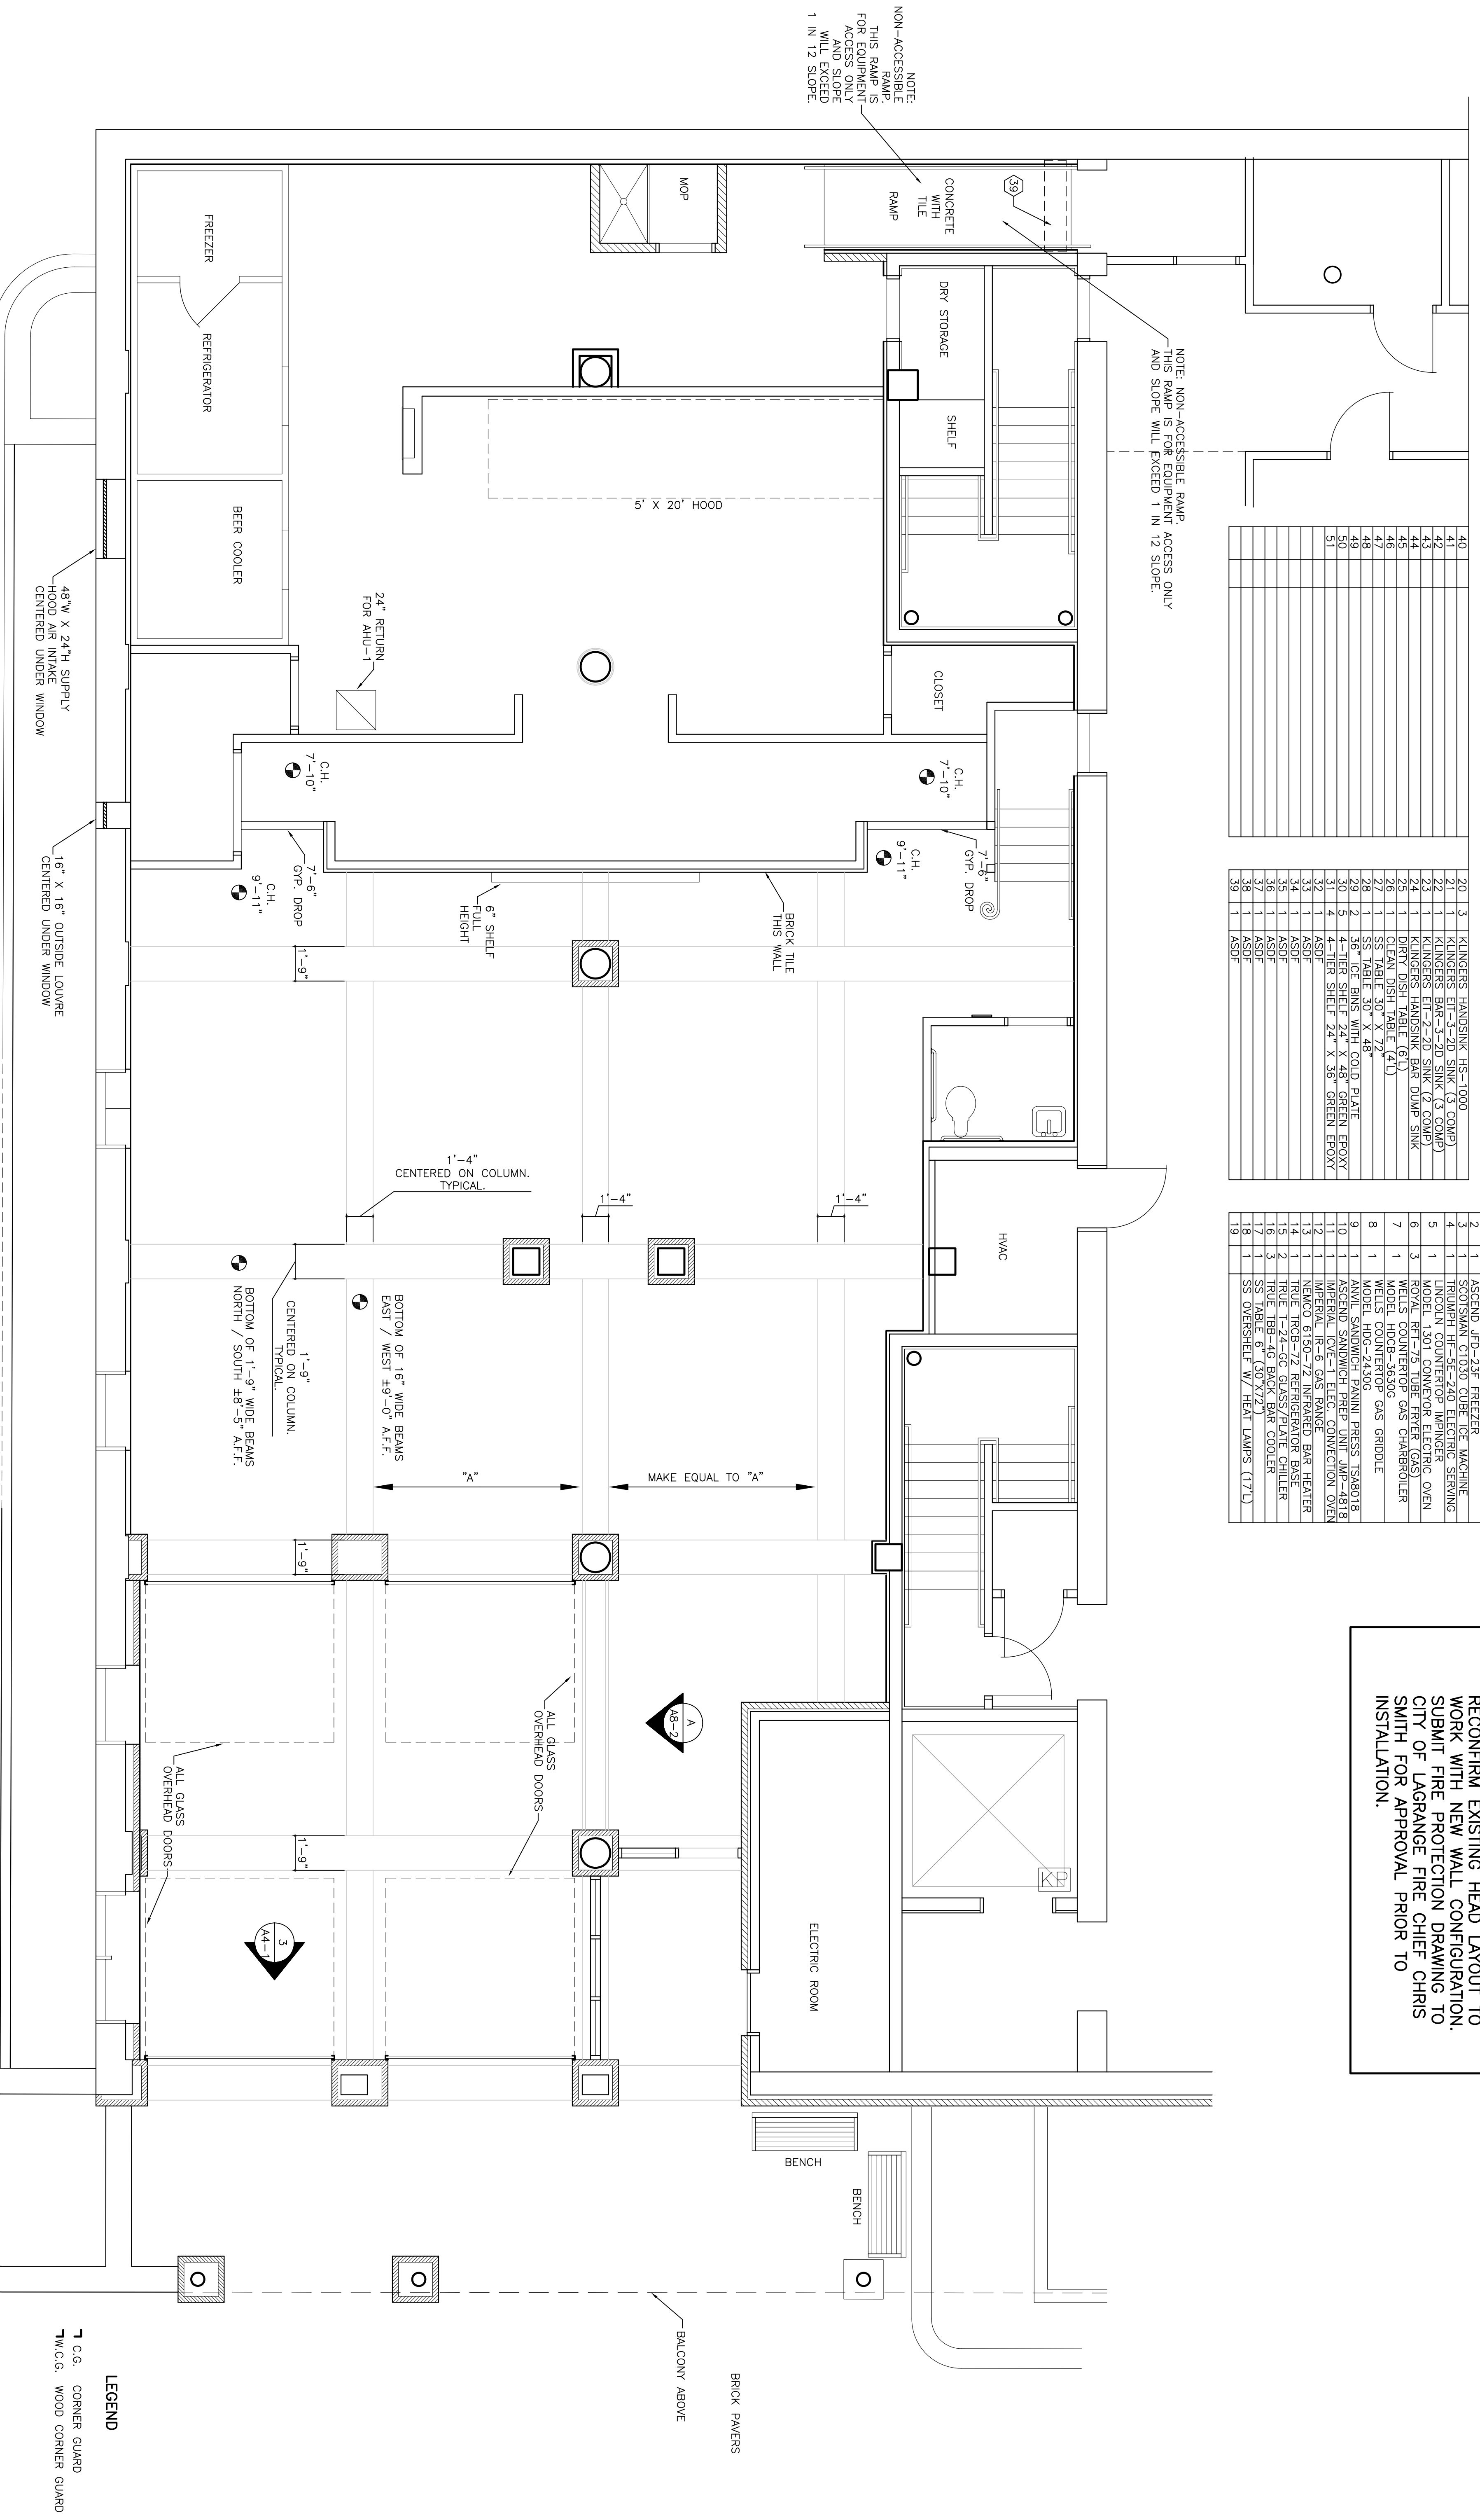

CONCEPT 'C'
REFLECTED CEILING PLAN
SCALE: 1/4" = 1'-0"
NORTH

ALL TABLES AND CHAIRS, BANQUETTE AND FURNITURE ARE NOT IN THE GENERAL CONTRACTORS SCOPE OF WORK.

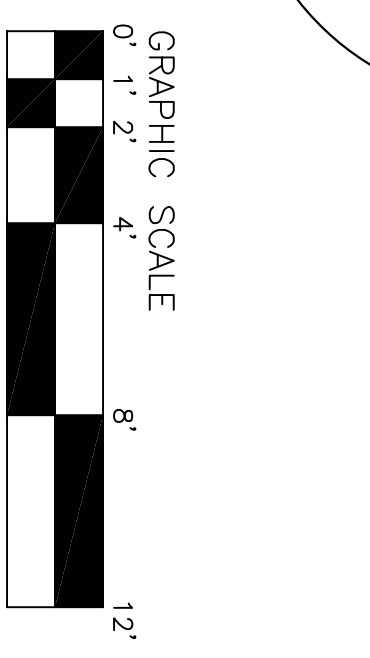

LEGEND
 1 C.G. CORNER GUARD
 2 W.C.G. WOOD CORNER GUARD

<p>SMITH DESIGN GROUP, INC. 307 Church Street LaGrange Phone (706) 882-5511</p>	<p>Suite B Georgia Fax (706) 883-7777</p>	<p>SHEET TITLE CONCEPT C REFLECTED CEILING PLAN</p>	<p>PROJECT TITLE THE BRICKHOUSE AT DEL' AVANT MAIN STREET LAGRANGE, GEORGIA</p>	<p>ARCHITECT'S STAMP </p>
		<p>DRAWN JTS 0911-R</p>	<p>CHECKED GMS 0911-R</p>	<p>DATE 17 JAN 2011</p>